




ELEVATION G

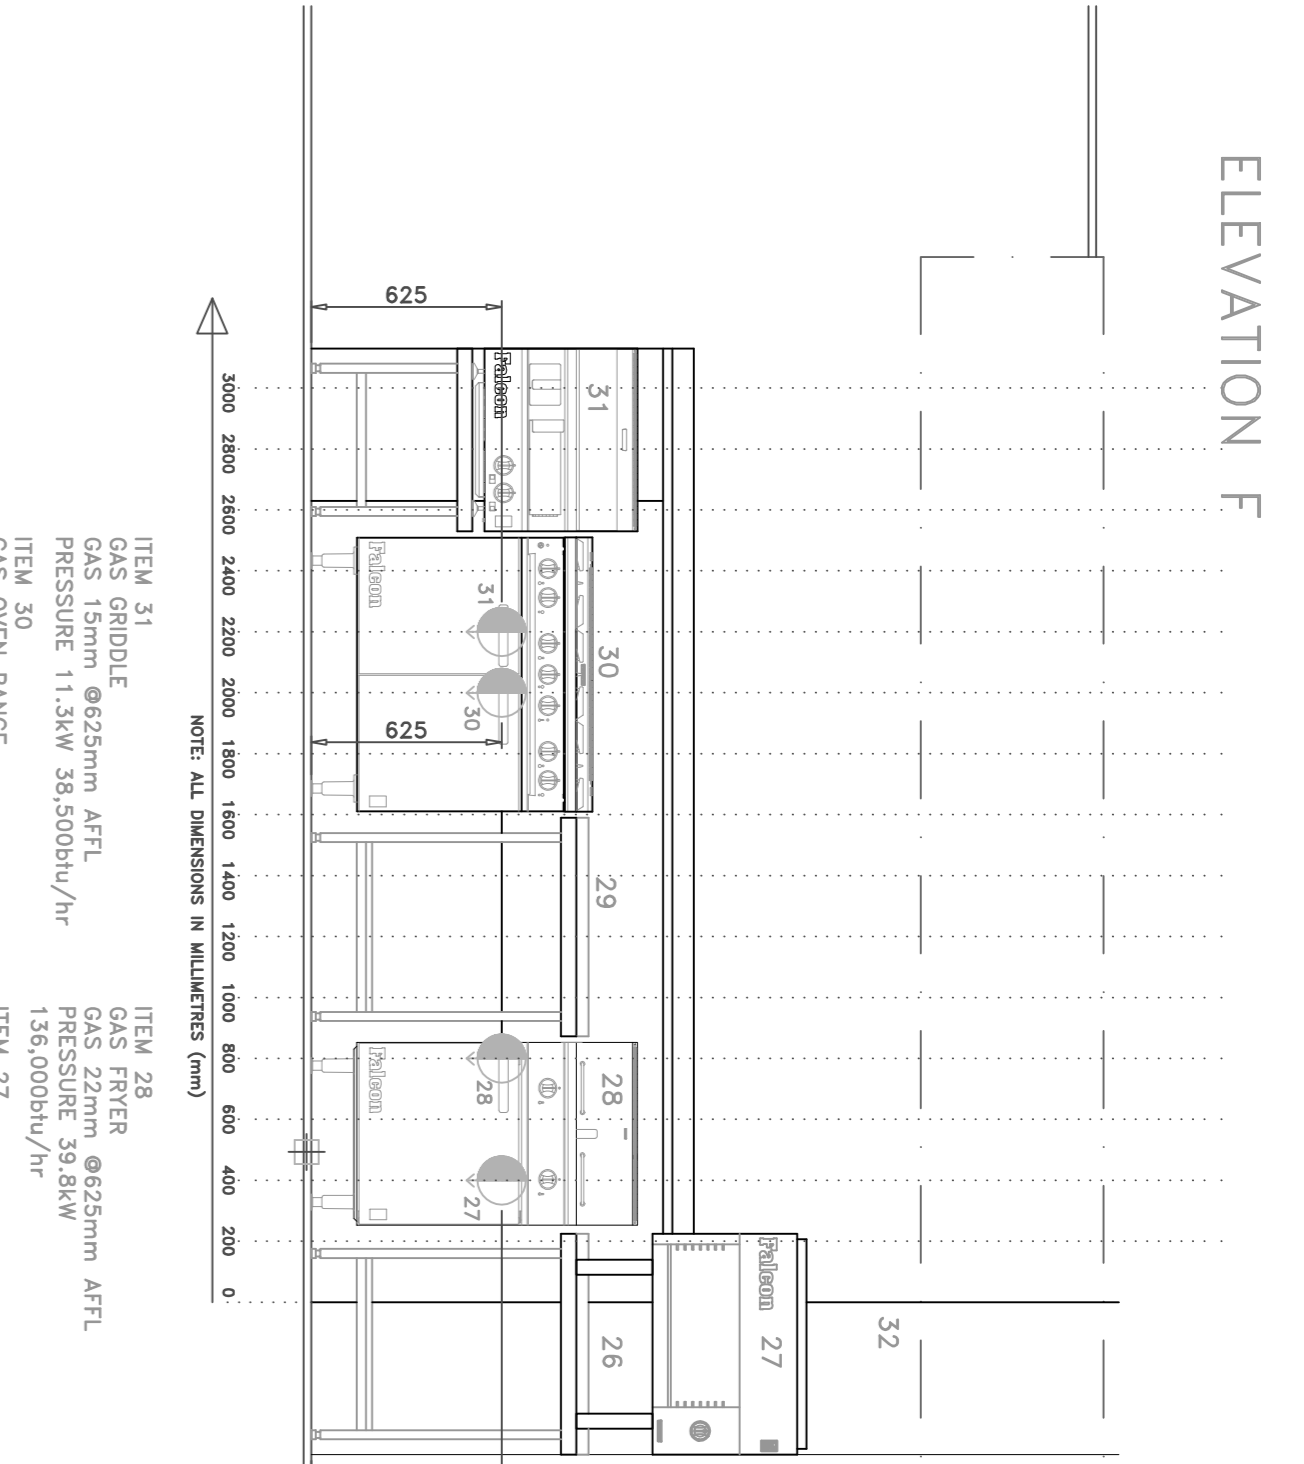


ELEVATION F

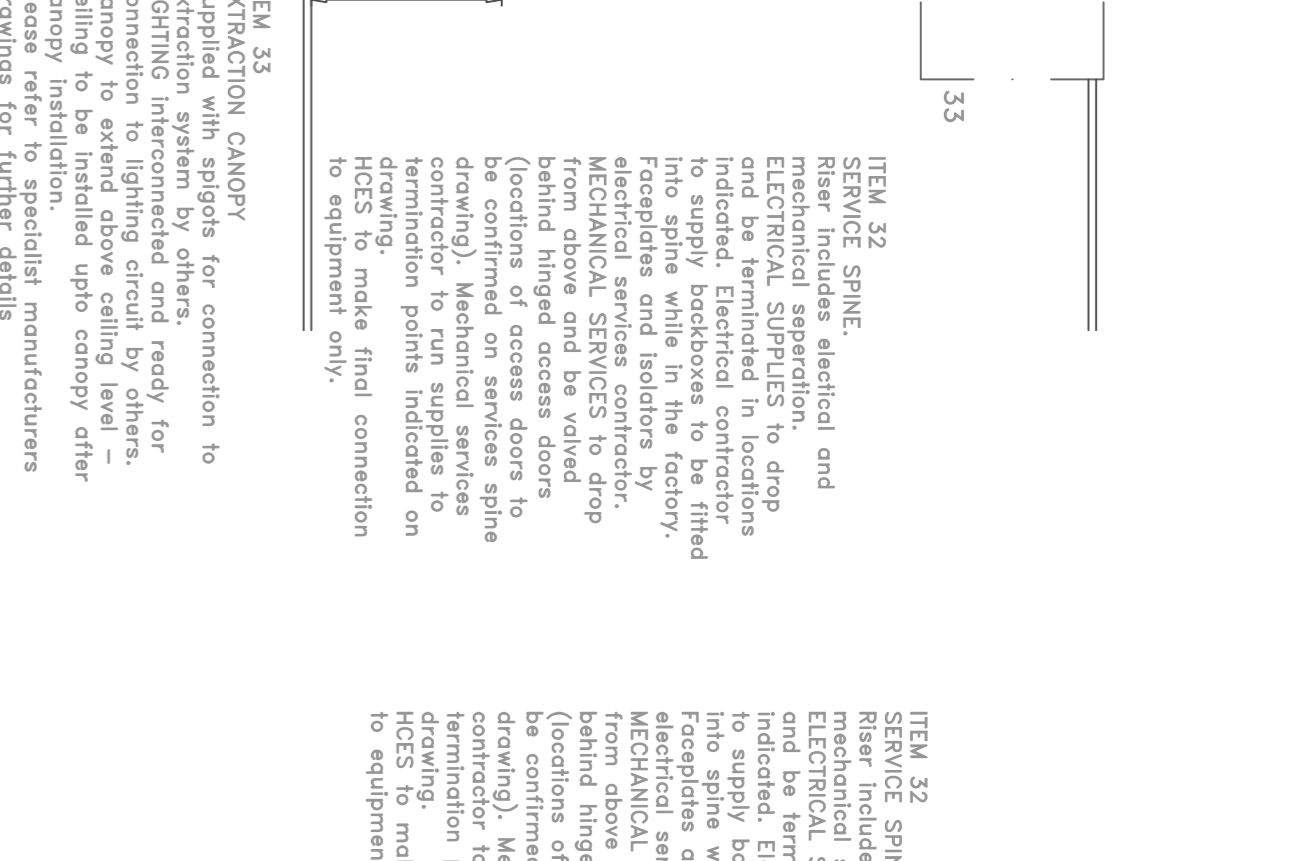


ELEVATION E

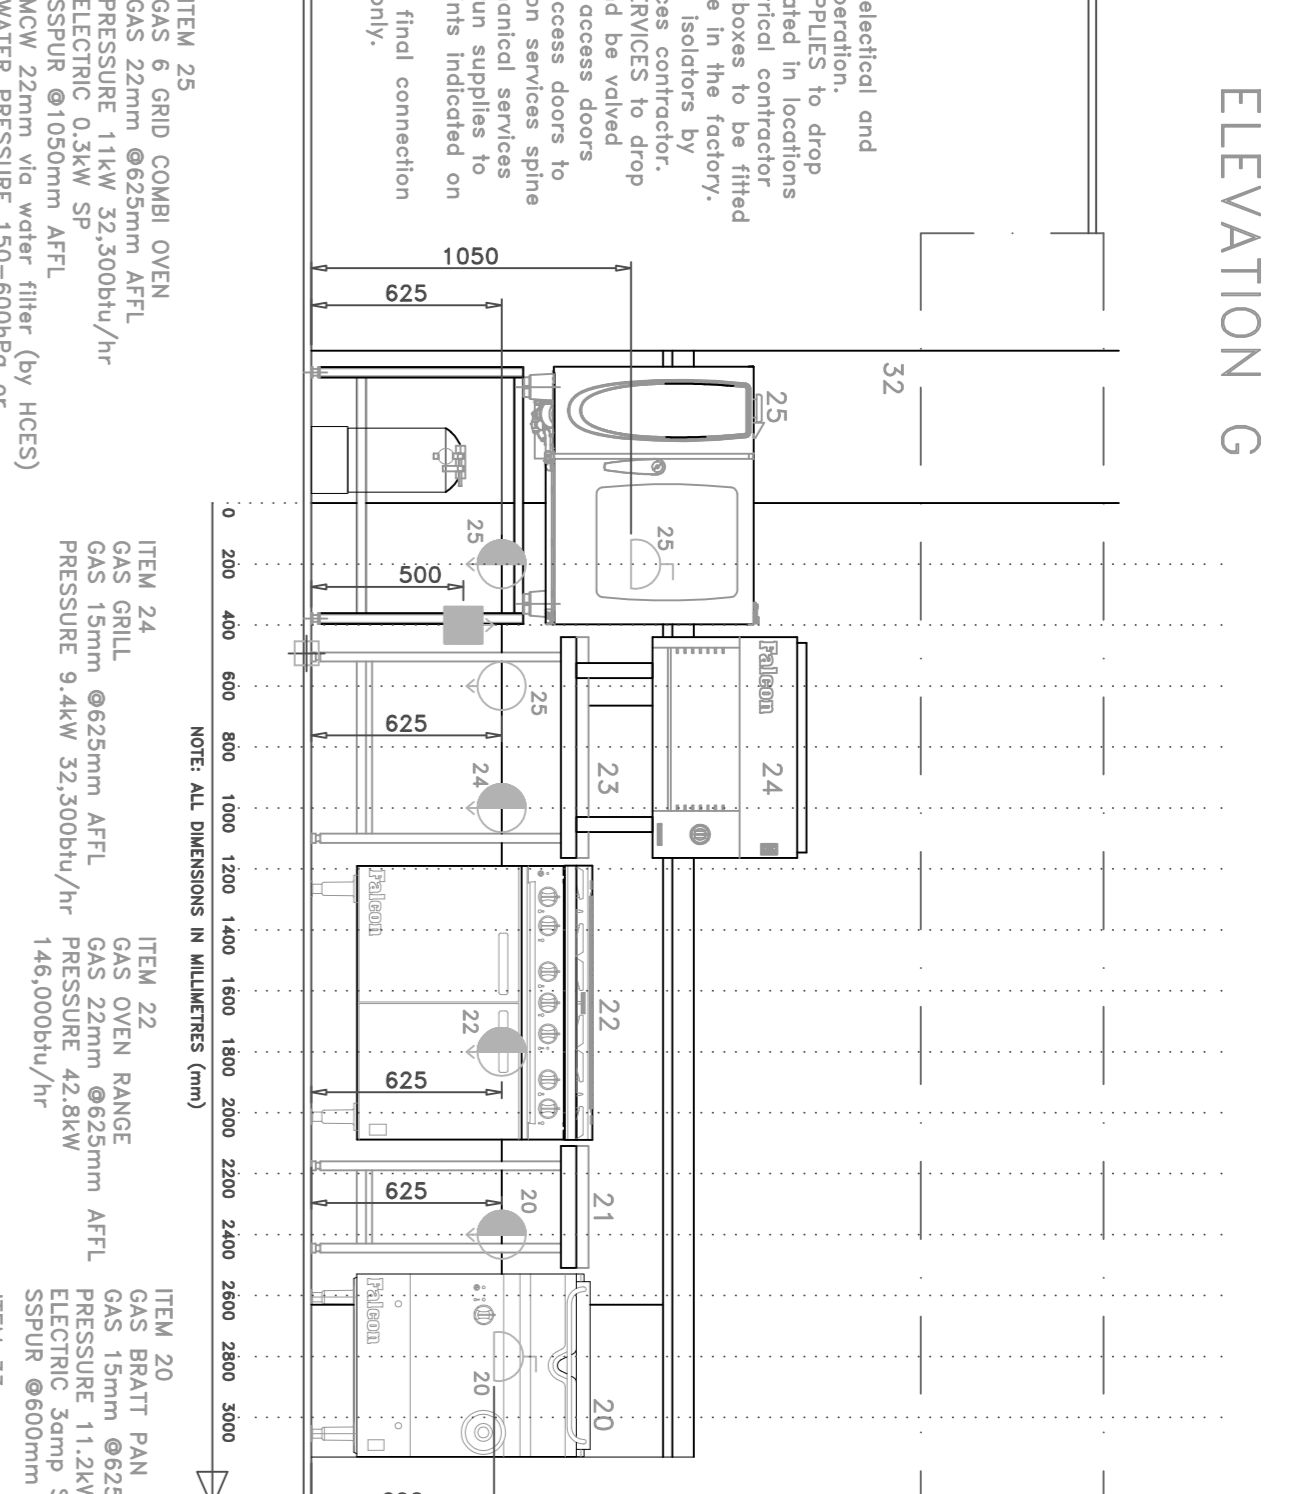


ELEVATION D

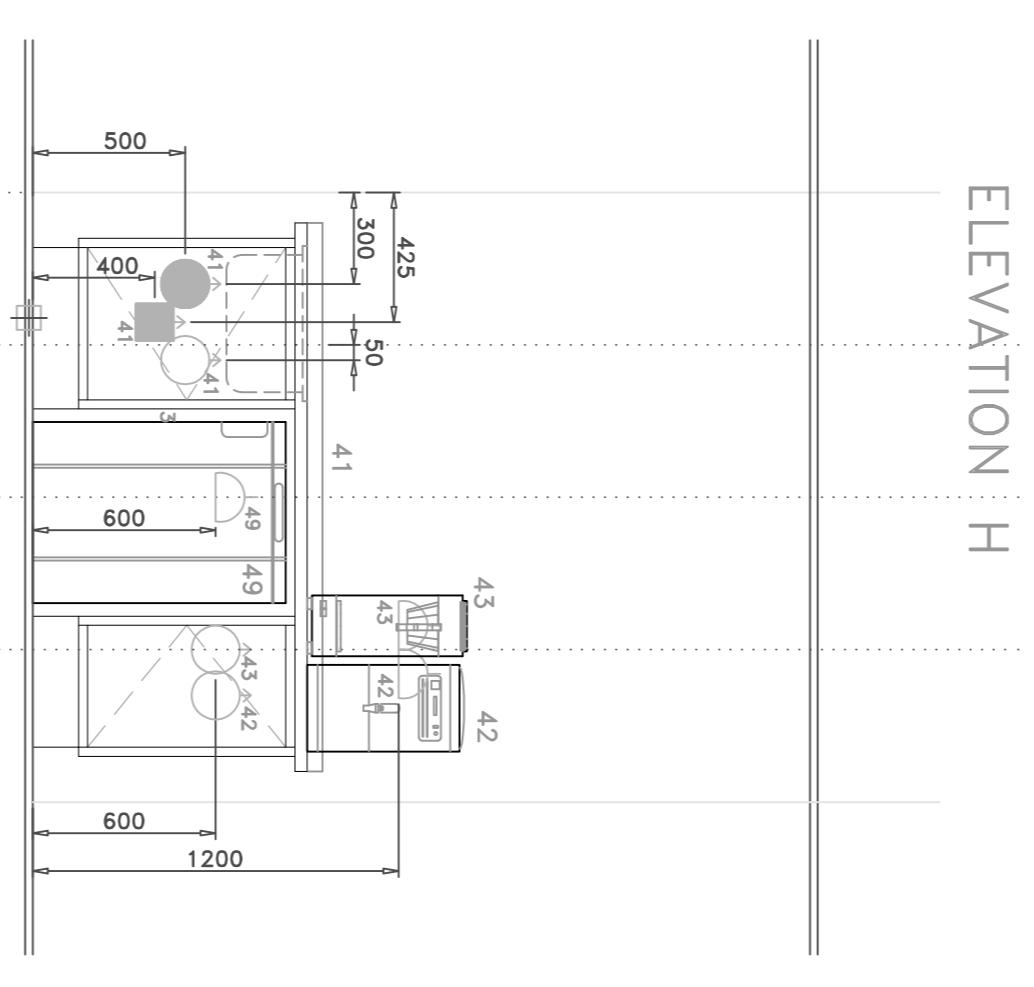


ELEVATION H

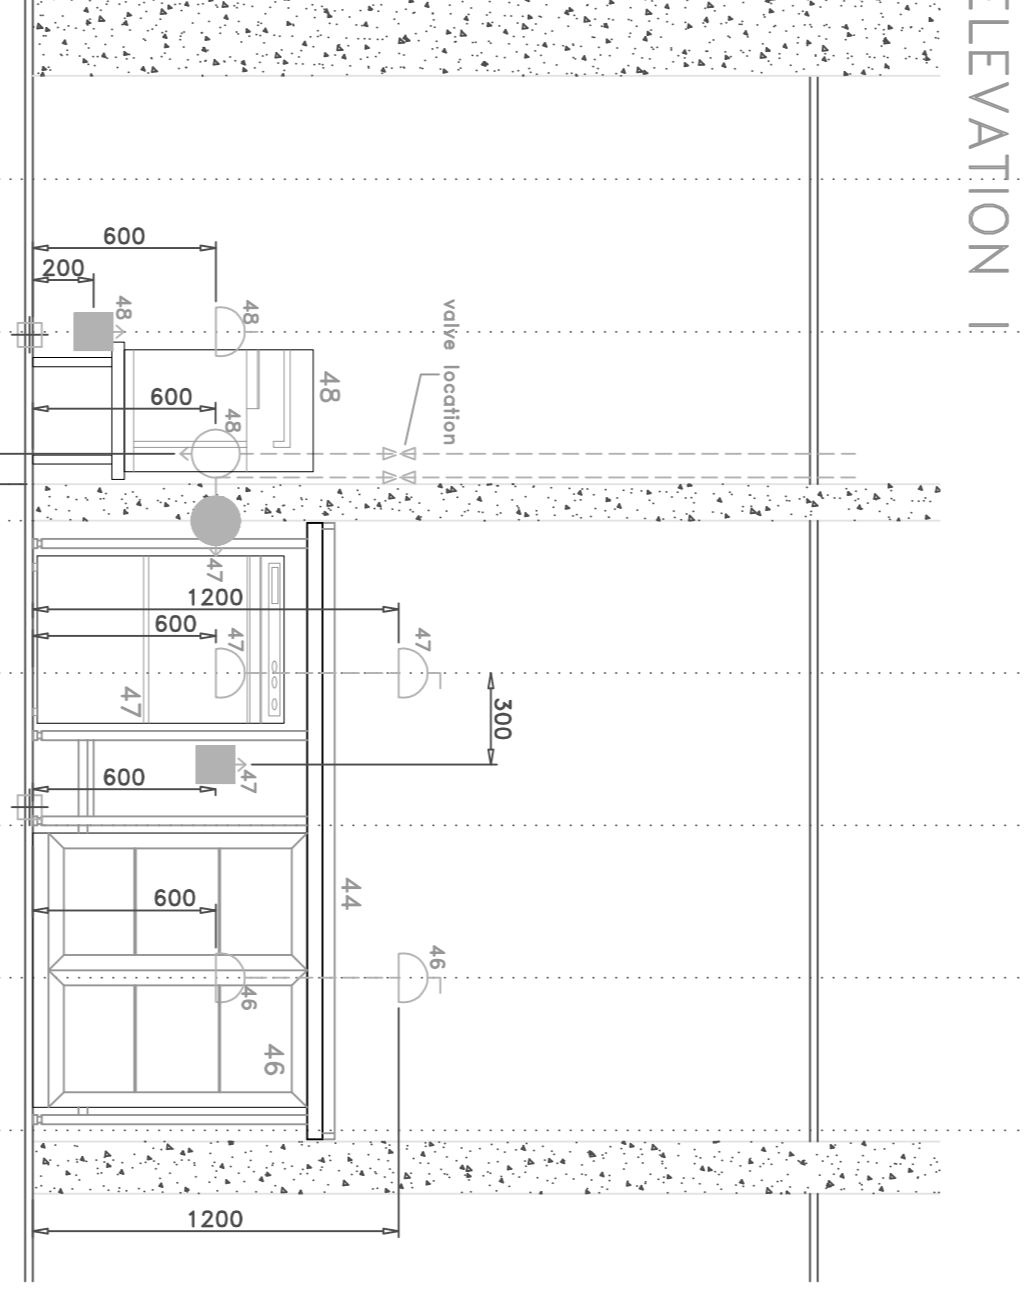

ELEVATION I

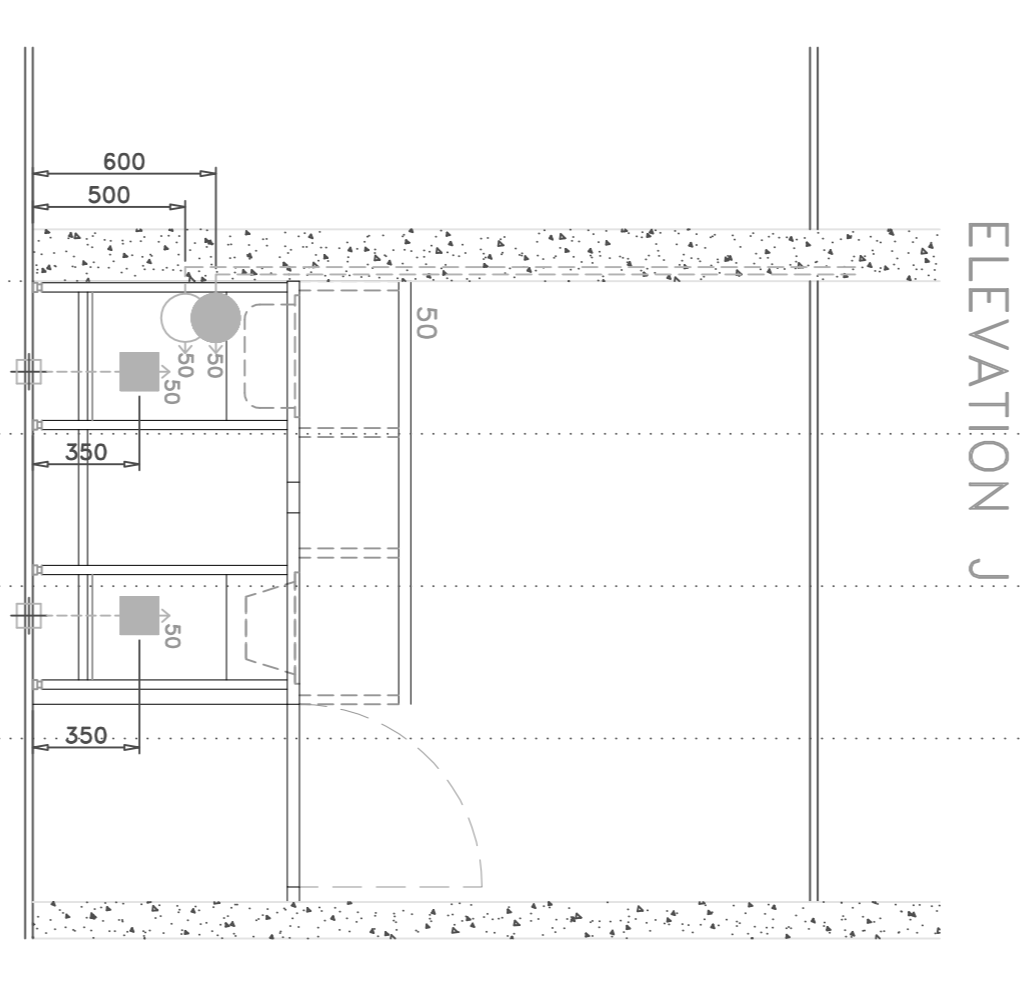

ELEVATION J

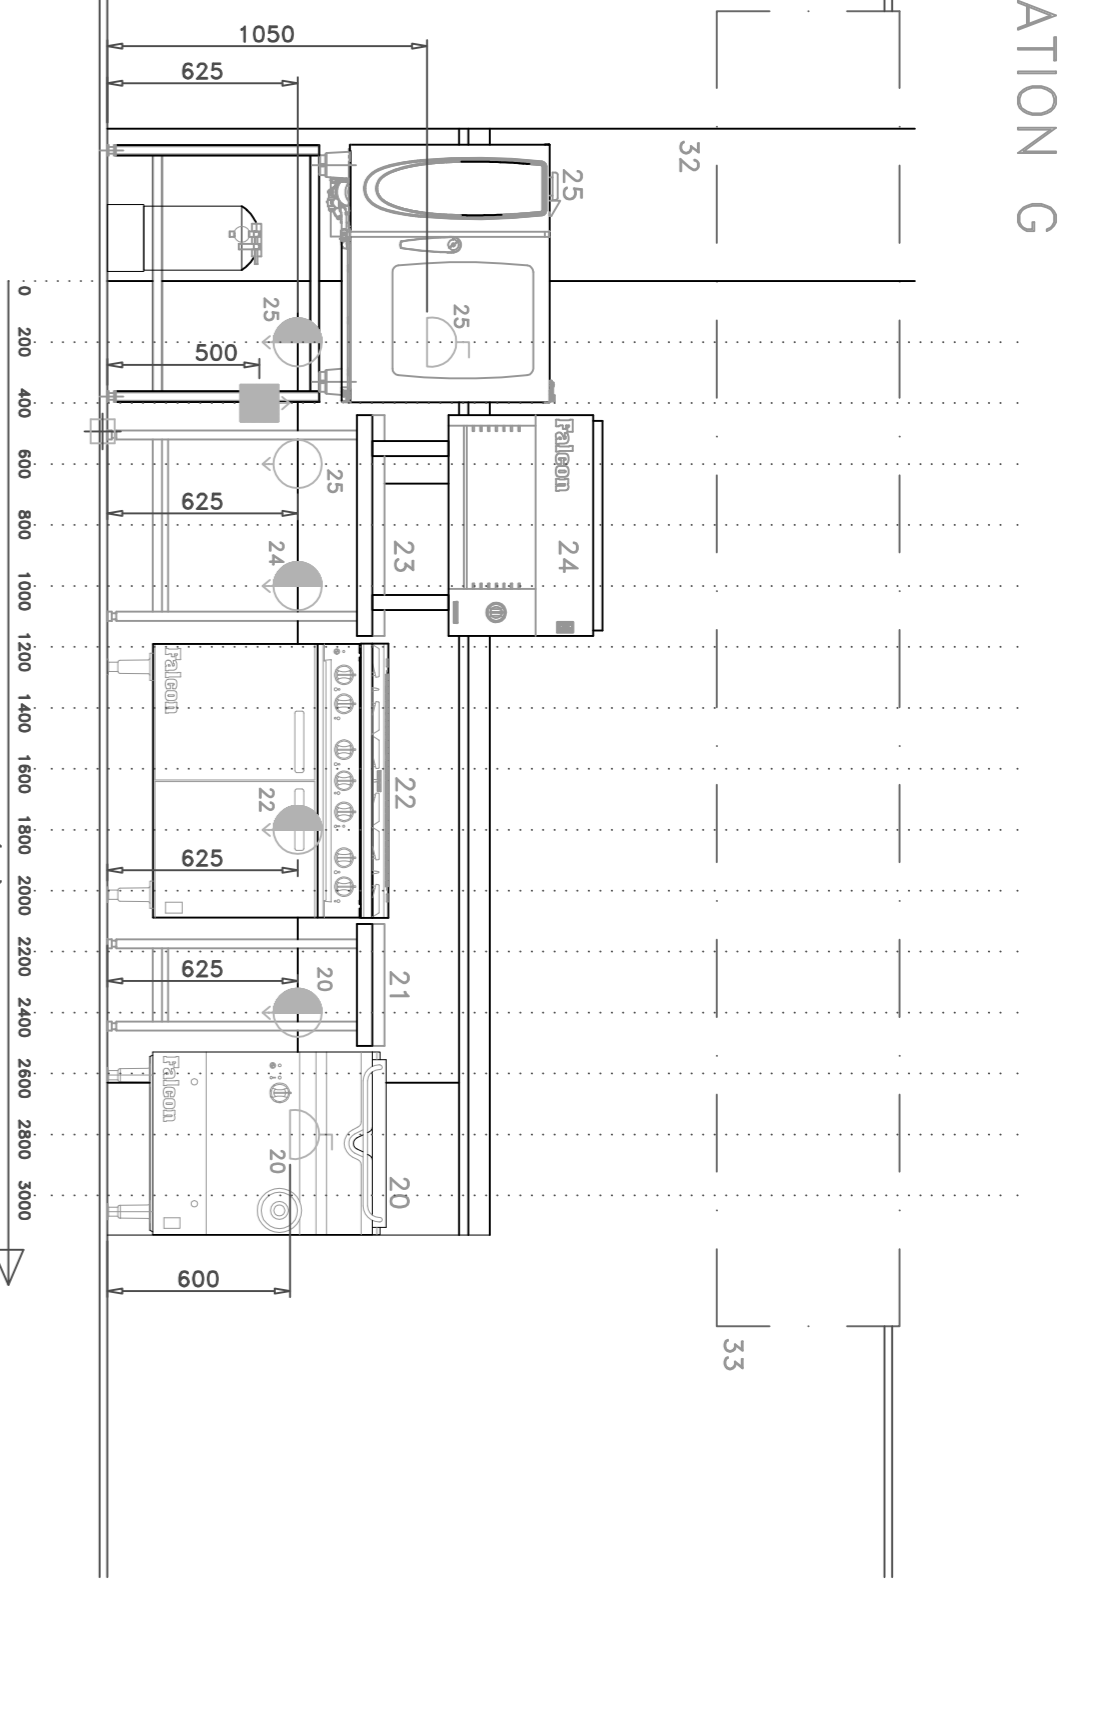


ELEVATION G

- ITEM 49 UNDERCOUNTER REFRIGERATOR
- ITEM 43 UNDERCOUNTER COFFEE FILTER MACHINE
- ITEM 42 WATER BOILER
- ITEM 48 ELECTRIC ICE MAKER
- ITEM 47 UNDERCOUNTER BOTTLE COOLER
- ITEM 50 SHOP FIT FRONT BAR


- ITEM 45 ELECTRIC 2.3kW SP
- ITEM 41 SINK UNIT
- ITEM 44 WASTE - MANUAL EMPTY
- ITEM 46 ELECTRIC 2.6kW SP
- ITEM 48 ELECTRIC 3500W SP
- ITEM 47 ELECTRIC 2.6kW SP
- ITEM 50 SHOP FIT FRONT BAR

- ITEM 25A WATER FILTER
- ITEM 29 S/S PREP BENCH
- ITEM 27 GAS DOUBLE PAN FRYER
- ITEM 28 GAS 6 BURNER OVEN RANGE
- ITEM 30 GAS GRIDDLE
- ITEM 31 S/S EXTRACTION CANOPY
- ITEM 32 COSH CUPBOARD
- ITEM 33 S/S CHINA RACKING
- ITEM 34 S/S WALL BENCH
- ITEM 35 S/S WALL BENCH
- ITEM 36 S/S WALL BENCH
- ITEM 37 OMITTED
- ITEM 38 ELECTRIC PEELER
- ITEM 39 POTATO PEELER
- ITEM 40 BENCH MOUNTED MIXER
- ITEM 41 S/S WALL BENCH
- ITEM 42 COFFEE MACHINE
- ITEM 43 S/S WALL BENCH
- ITEM 44 S/S WALL BENCH
- ITEM 45 SPARE NUMBER
- ITEM 46 UNDERCOUNTER BOTTLE COOLER
- ITEM 47 UNDERCOUNTER GLASSWASHER
- ITEM 48 UNDERCOUNTER ICE MACHINE
- ITEM 49 UNDERCOUNTER REFRIGERATOR
- ITEM 50 SHOP FIT FRONT BAR

- ITEM 20 GAS BRATT PAN
- ITEM 21 S/S PREP BENCH
- ITEM 22 S/S PREP BENCH
- ITEM 23 S/S PREP BENCH
- ITEM 24 GAS BRATT PAN
- ITEM 25 GAS 6 BURNER OVEN RANGE
- ITEM 26 GAS 6 BURNER OVEN RANGE
- ITEM 27 GAS DOUBLE PAN FRYER
- ITEM 28 GAS 6 BURNER OVEN RANGE
- ITEM 29 S/S PREP BENCH
- ITEM 30 GAS GRIDDLE
- ITEM 31 S/S EXTRACTION CANOPY
- ITEM 32 COSH CUPBOARD
- ITEM 33 S/S CHINA RACKING
- ITEM 34 S/S WALL BENCH
- ITEM 35 S/S WALL BENCH
- ITEM 36 S/S WALL BENCH
- ITEM 37 OMITTED
- ITEM 38 ELECTRIC PEELER
- ITEM 39 POTATO PEELER
- ITEM 40 BENCH MOUNTED MIXER
- ITEM 41 S/S WALL BENCH
- ITEM 42 COFFEE MACHINE
- ITEM 43 S/S WALL BENCH
- ITEM 44 S/S WALL BENCH
- ITEM 45 SPARE NUMBER
- ITEM 46 UNDERCOUNTER BOTTLE COOLER
- ITEM 47 UNDERCOUNTER GLASSWASHER
- ITEM 48 UNDERCOUNTER ICE MACHINE
- ITEM 49 UNDERCOUNTER REFRIGERATOR
- ITEM 50 SHOP FIT FRONT BAR

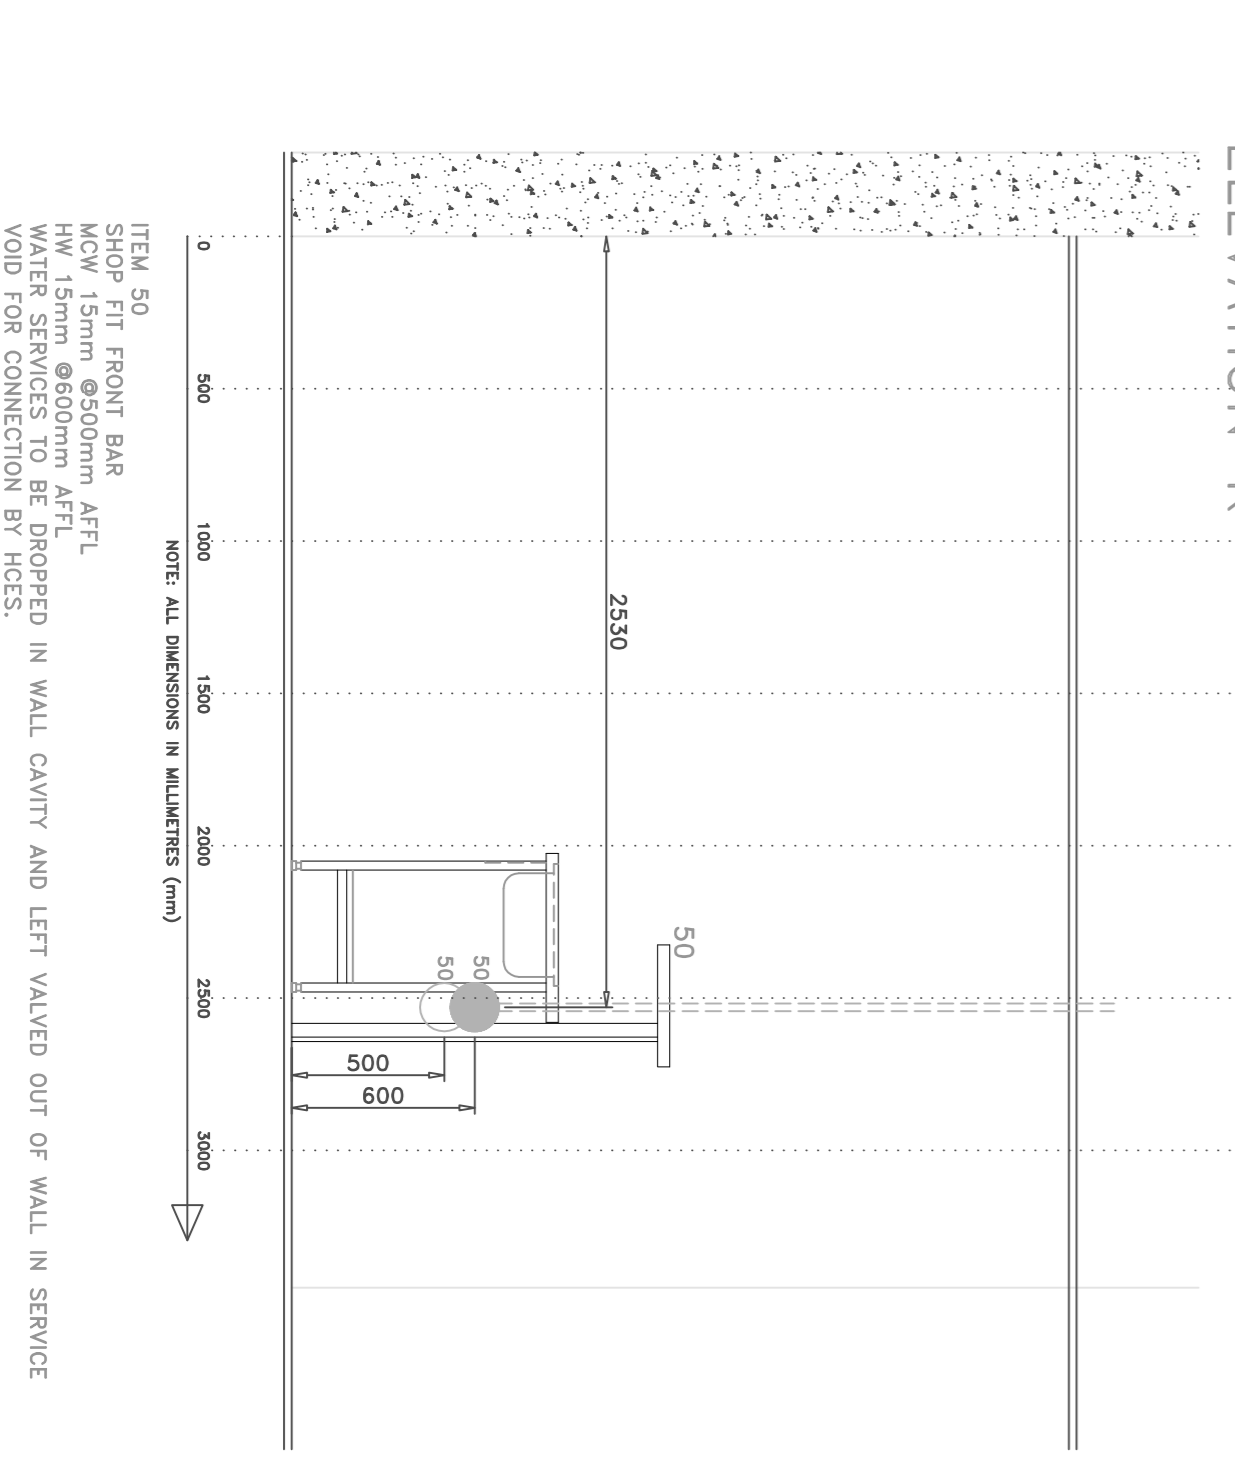


ELEVATION K

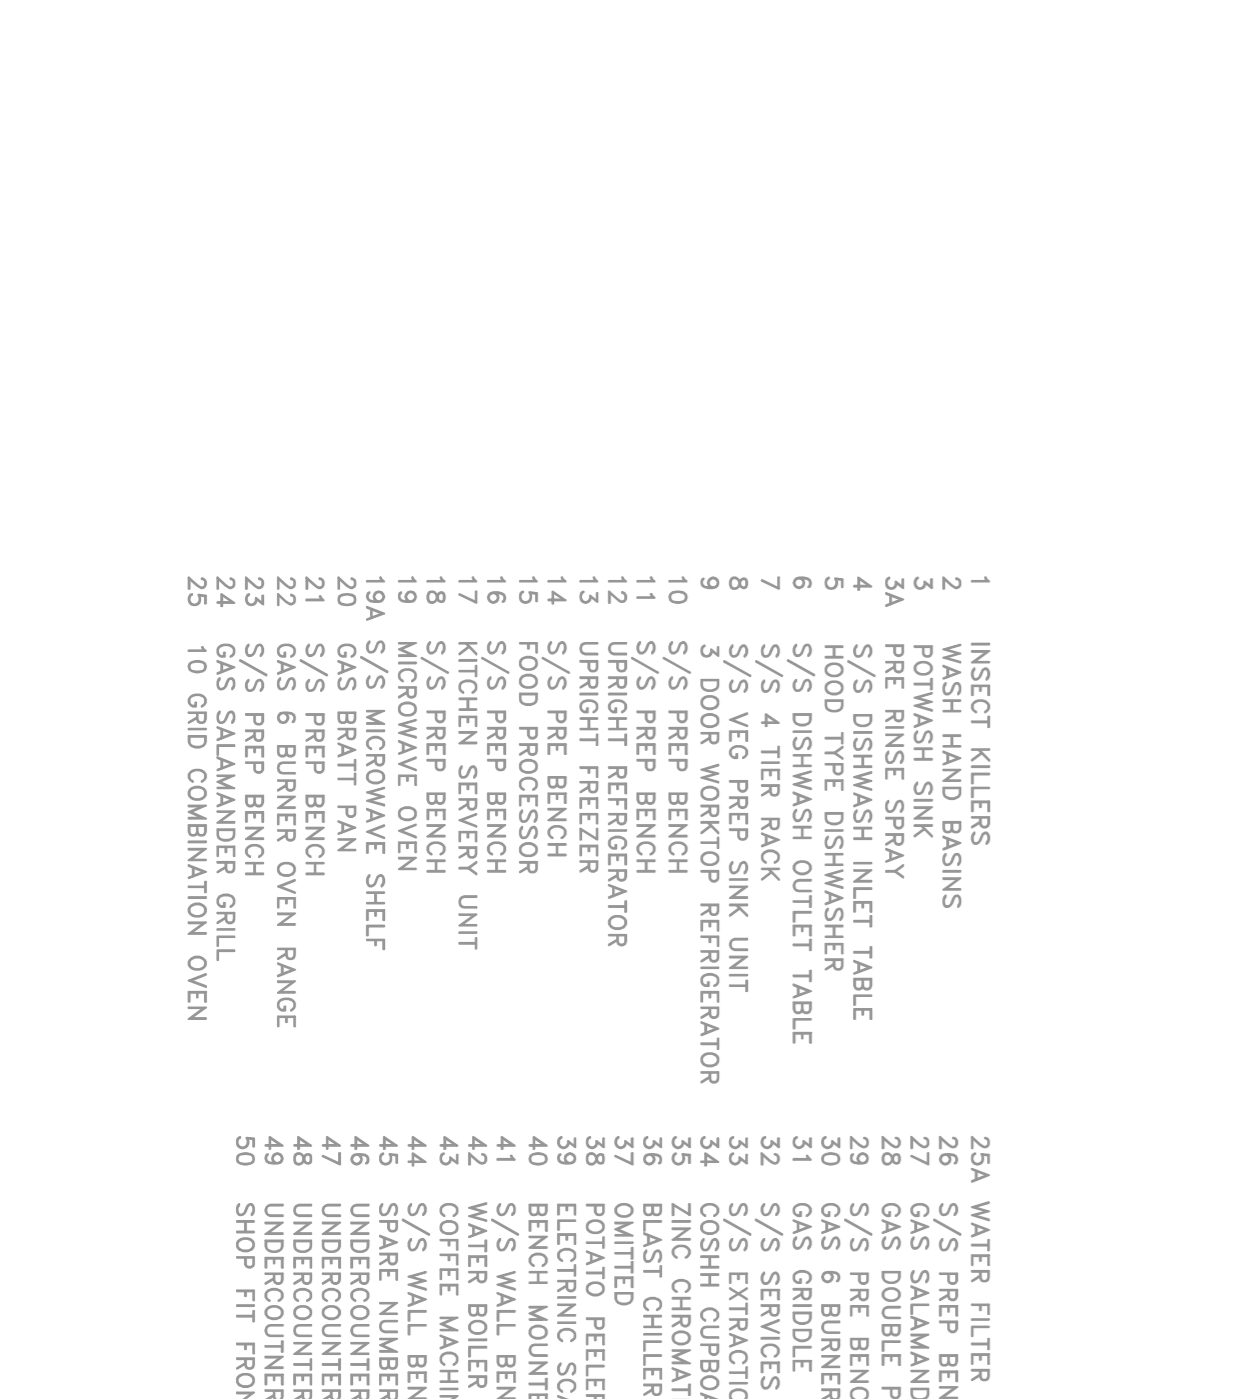


ELEVATION L



ELEVATION M

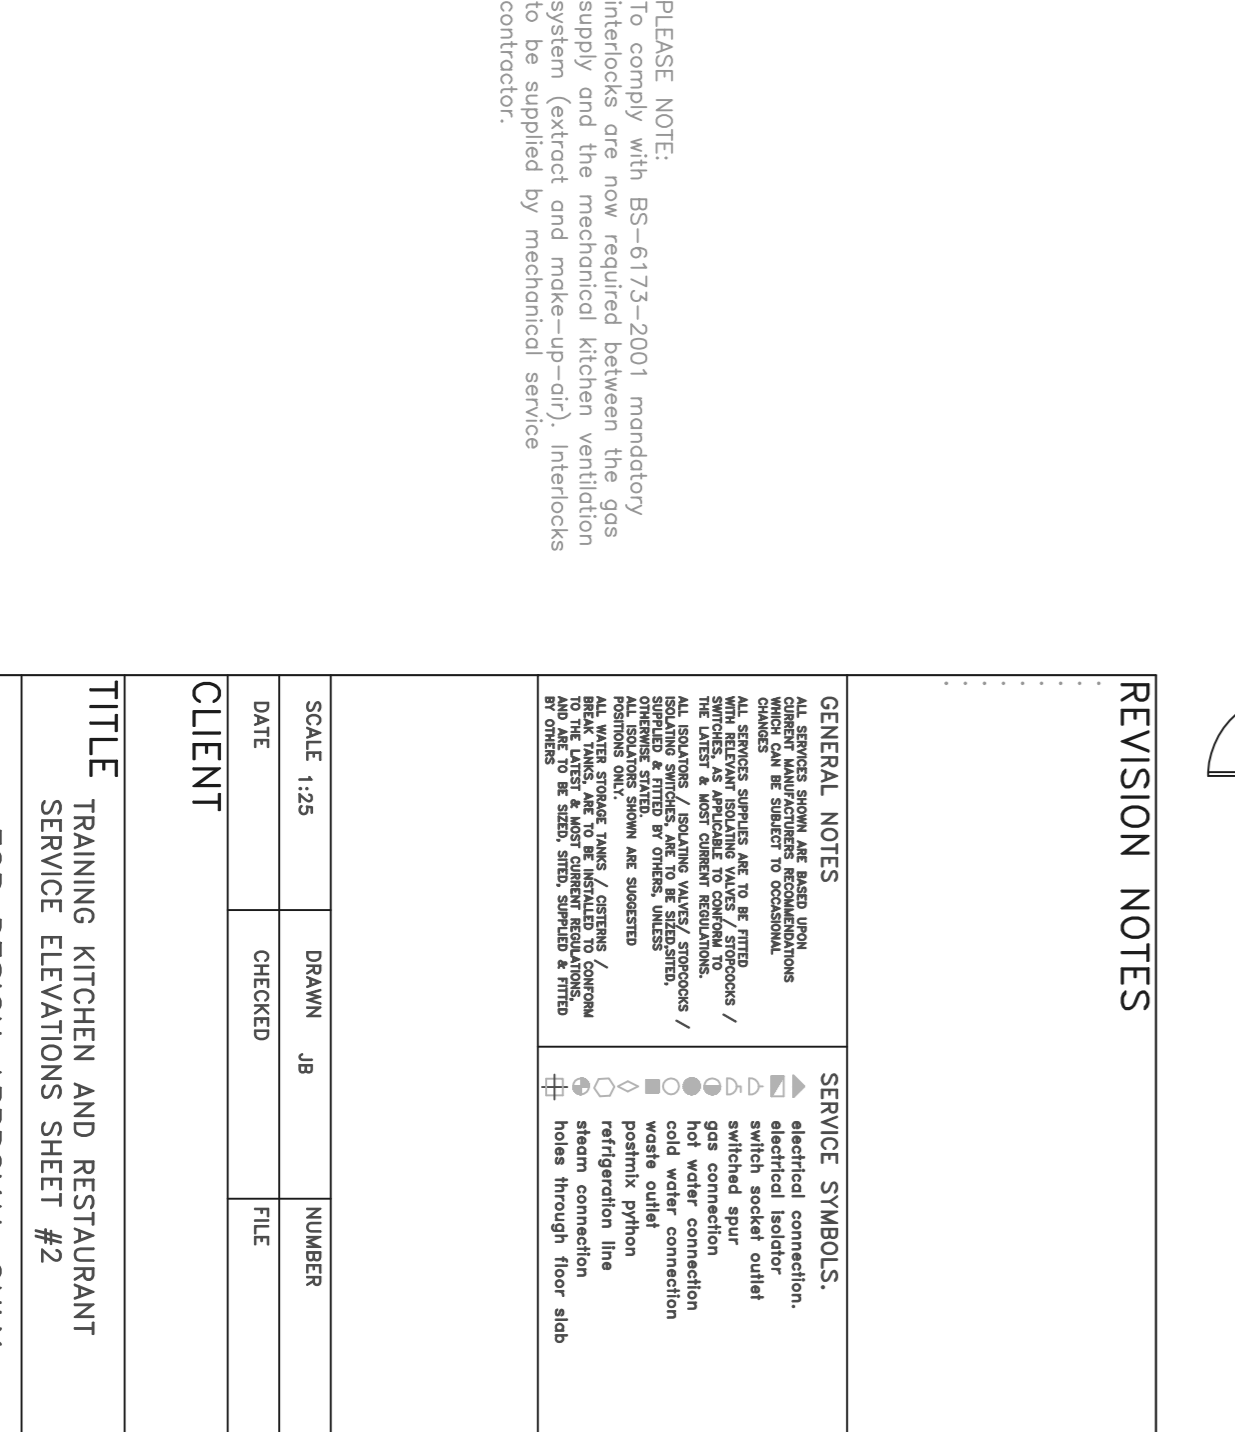

ELEVATION N

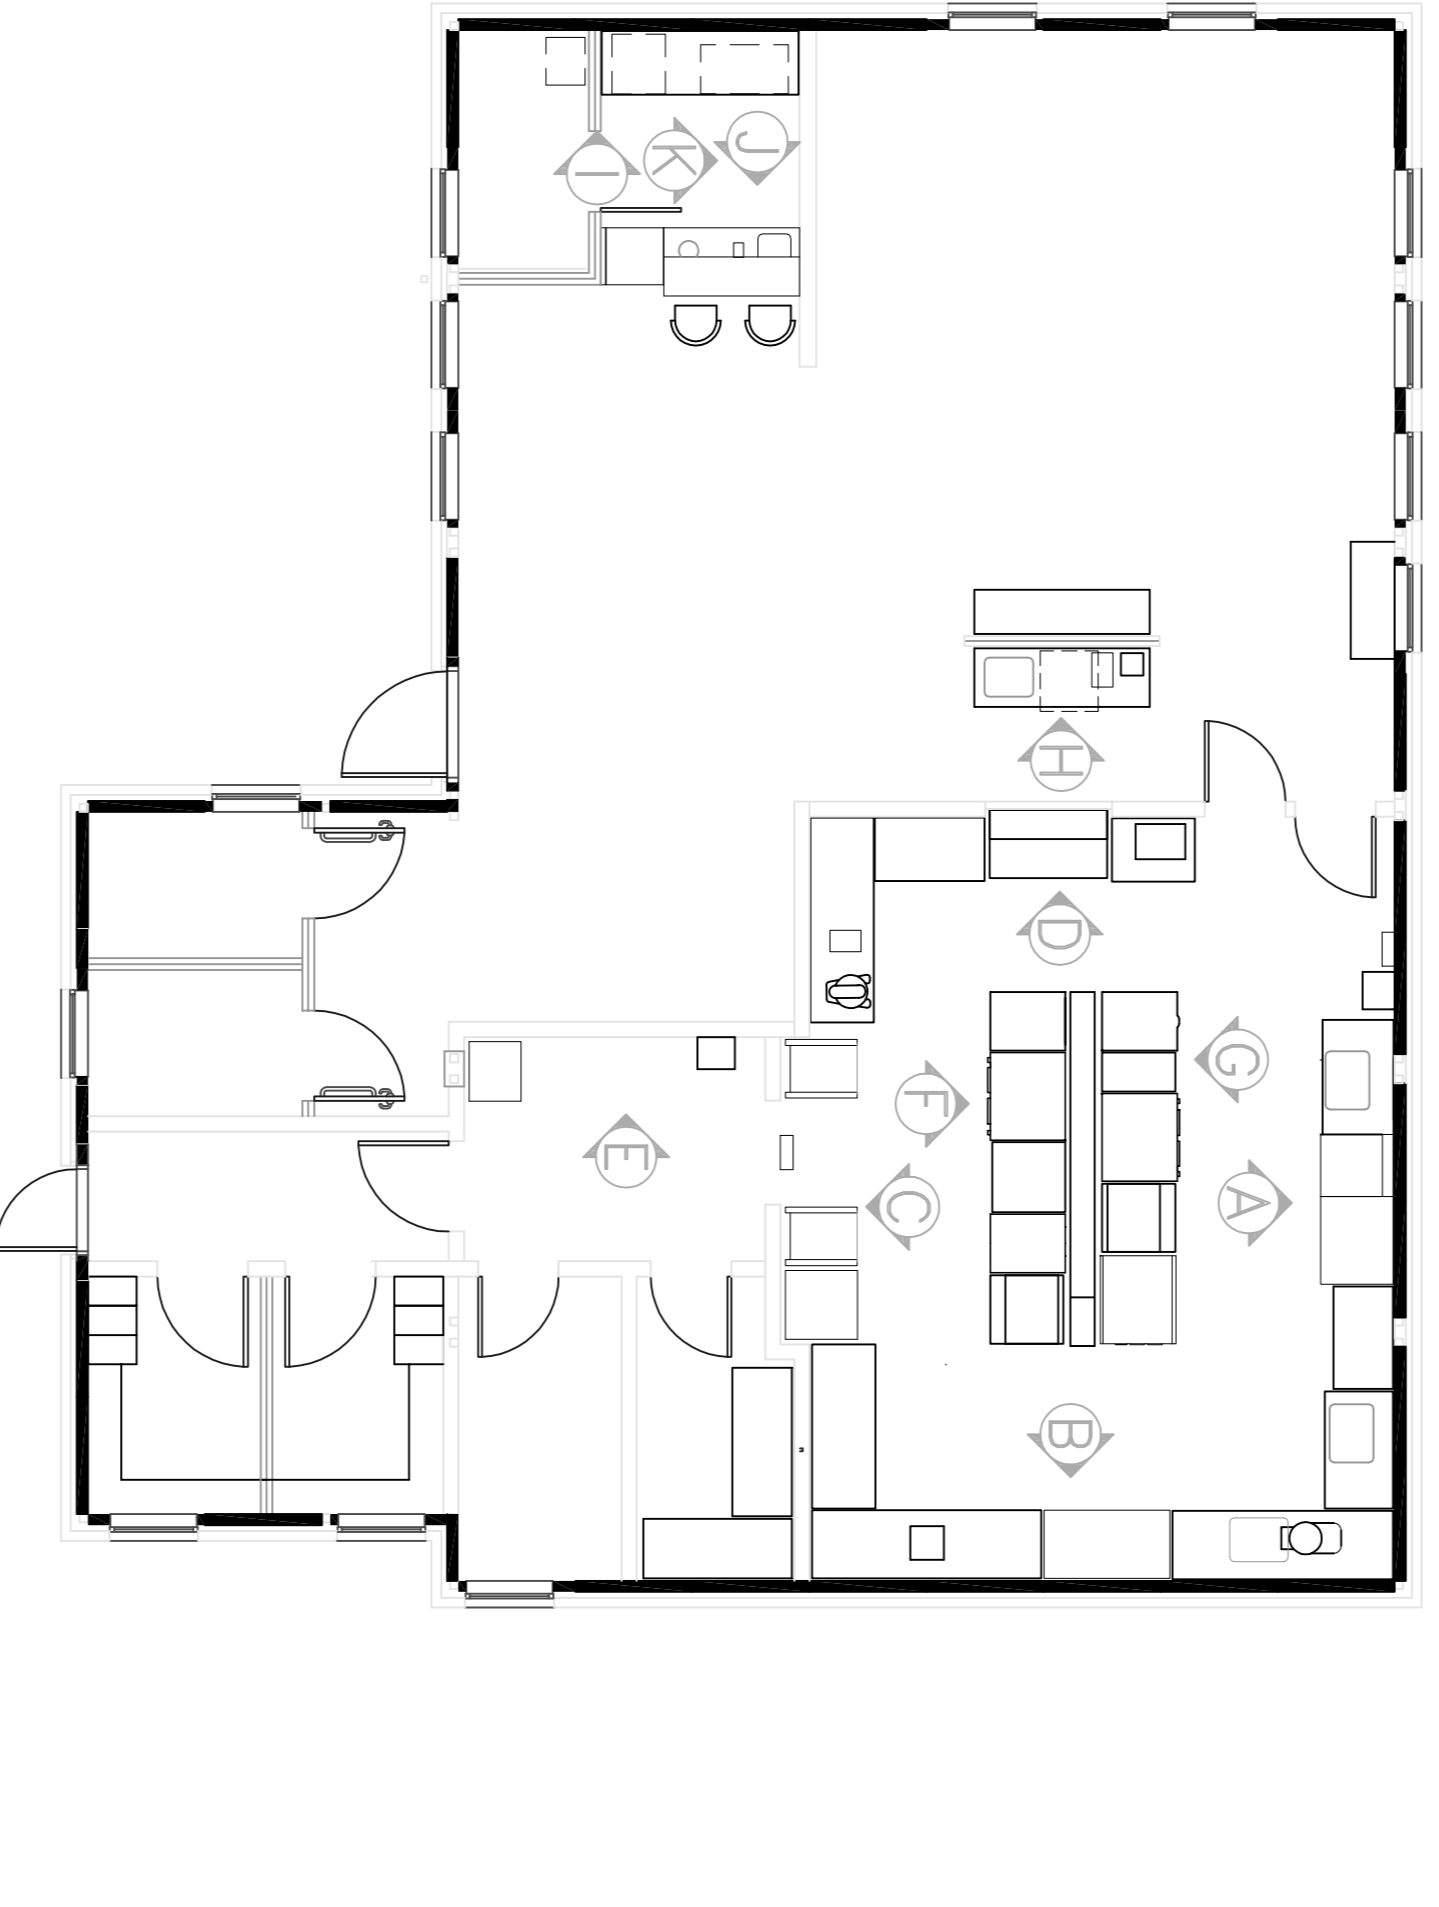

**GENERAL NOTES:**

- ALL WALLS ASSUMED TO BE BLOCKWORK UNLESS OTHERWISE INFORMED THEREFORE RE-ENFORCEMENT FOR WALL MOUNTED EQUIPMENT
- GENERAL PURPOSE SOCKET LOCATIONS TO BE CONFIRMED BY OTHERS. NOT TO CONTRAVENE CURRENT REGULATIONS.
- ANY SURFACE RUN SERVICES MUST NOT FINISHED WALL SURFACE RUN SERVICES MUST NOT CLASH WITH EQUIPMENT BEING INSTALLED TO WALLS.
- ALL SERVICES TO BE SUITABLY ISOLATED WITHIN 1MTR OF FINAL CONNECTION POINTS BY OTHERS

**PLEASE NOTE:**

Interlocks shall be used for the fire alarm system (extract and make-up-air), interlocks to be supplied by mechanical service contractor.

**REVISION NOTES**

| NO. | DATE | DESCRIPTION |
|-----|------|-------------|
|     |      |             |
|     |      |             |

| SCALE | DRAWN | NUMBER |
|-------|-------|--------|
| 1:25  | JB    |        |

| CLIENT | CHECKED | FILE |
|--------|---------|------|
|        |         |      |

**TITLE** TRAINING KITCHEN AND RESTAURANT  
SERVICE ELEVATIONS SHEET #2

FOR DESIGN APPROVAL ONLY  
THIS DRAWING SHOULD NOT BE USED FOR SERVICE DETAILS  
THE DRAWING CONTRACTOR SHALL BE RESPONSIBLE FOR CHECKING